


APPENDIX "B"

DRAWINGS:

TO ACCOMPANY THE ESGENOÔPETITJ FIRST NATION
EIA REGISTRATION DOCUMENT FOR THE UPGRADING OF THE
WASTEWATER COLLECTION AND TREATMENT SYSTEM

- Drawing 12145-1P-C101 "Site Plan"
- Drawing 12145-1P-C102 "Existing Wastewater System Details"
- Drawing 12145-1P-C105B "Collection System Modifications and New Outfall Plan Options 2 & 3"
- Drawing 12145-1P-C106B "New Aerated Lagoon with Future SAGR Option 2"
- Drawing 14239-1D-C08 "Outfall Plan and Profile Sta. 0+000 to 0+330"
- Drawing 14239-1D-C09 " "Outfall Plan and Profile Sta. 0+330 to 0+590"

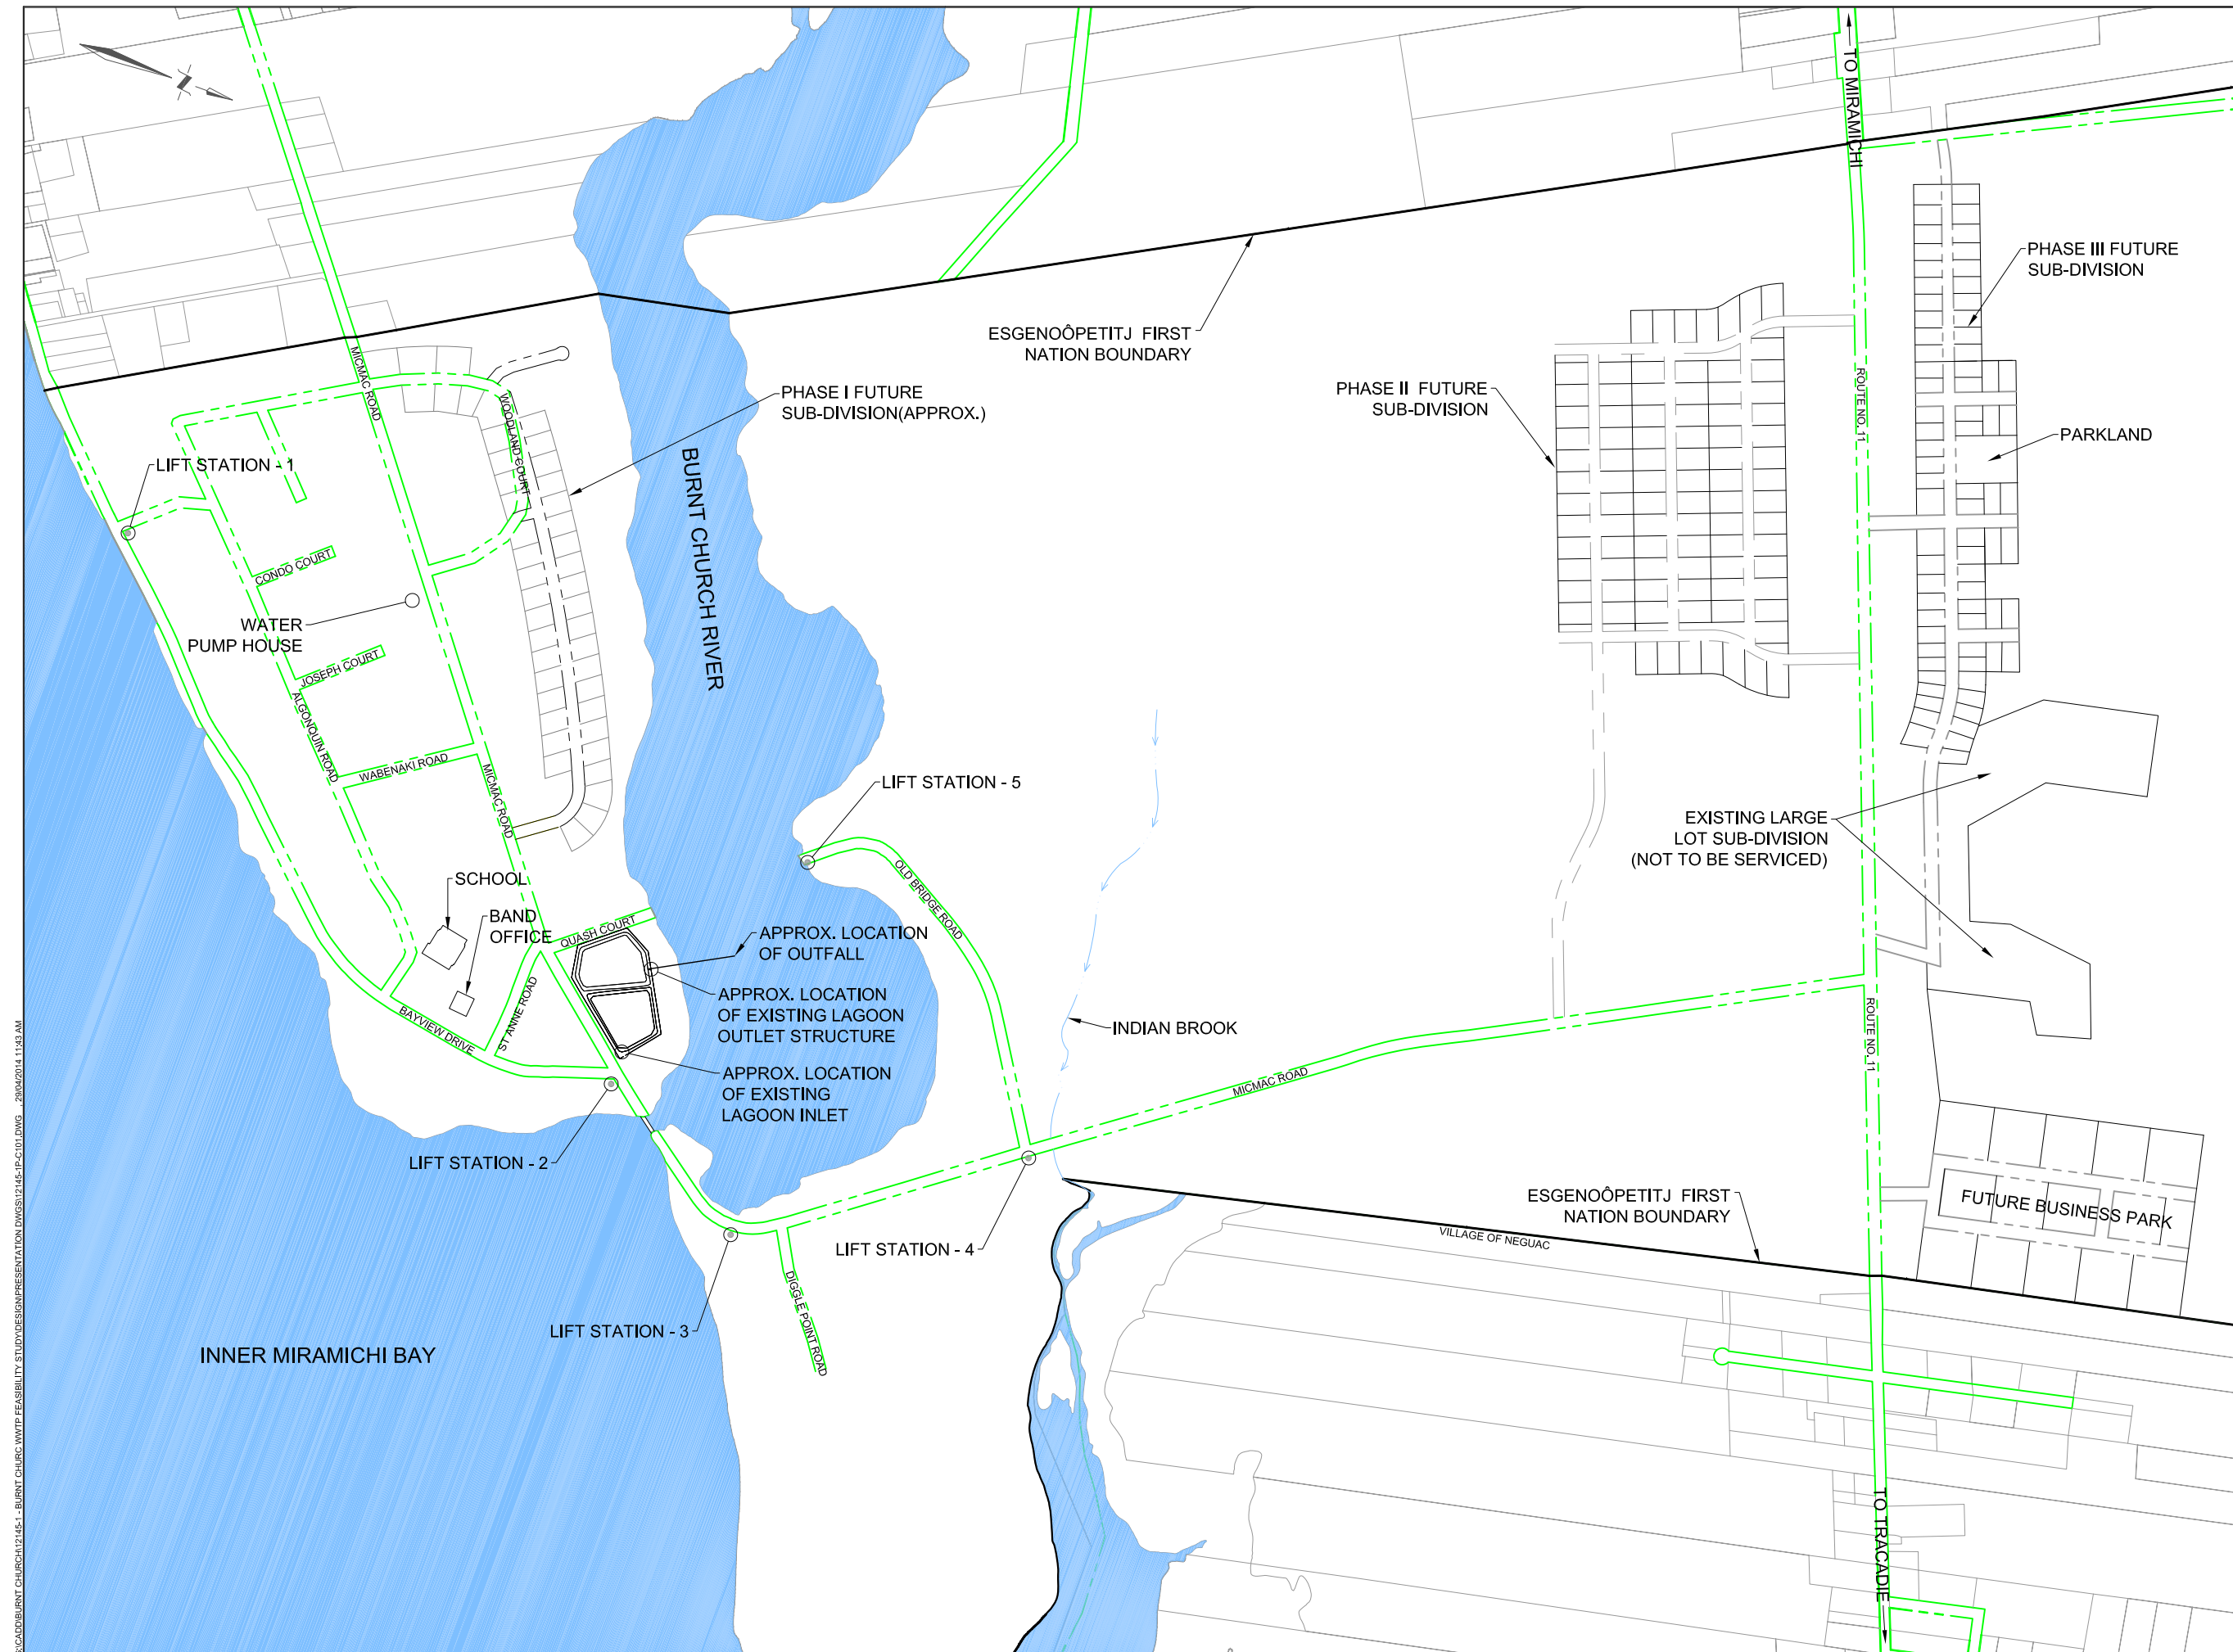

C:\CAD\BURNT CHURCH\12145-1P-C101.DWG - BURNT CHURCH WWTP FEASIBILITY STUDY\DESIGN PRESENTATION\DWG\12145-1P-C101.DWG - 28/04/2014 11:43 AM

NOTES

LEGEND

- RIGHT OF WAY
- WATERCOURSE

02	APR 17/14	ISSUED FOR REVIEW	BM	LEL
01	APR 07/14	ISSUED FOR REPORT	RCG	LEL
00	MAR 11/14	ISSUED FOR REVIEW	BM	LEL
NO.	DATE	REVISIONS	BY	APPR.



PRELIMINARY ONLY
DATE PLOTTED: APR 17/14
NOT TO BE USED FOR CONSTRUCTION

PROJECT TITLE		
ESGENOÛPETITJ WWTF FEASIBILITY STUDY		
BURNT CHURCH	N.B.	
DRAWING TITLE		
SITE PLAN		
Scale	Drawn By	Design By
N.T.S.	BM	LEL
	Checked By LEL	Cadd Check GMG
	Sheet 1 of 10	
File Name		
12145-1P-C101.DWG		
Drawing No.		
12145-1P-C101		



C:\CAD\BURNT CHURCH\12145-1-BURNT CHURCH WWTF FEASIBILITY STUDY\DESIGN PRESENTATION\DWG\12145-1P-C102.DWG - 2/20/2014 11:43 AM

NOTES

LEGEND


- GRAVITY MAIN
- - - FORCEMAIN
- - - RIGHT OF WAY

02	APR 17/14	ISSUED FOR REVIEW	BM	LEL
01	APR 07/14	ISSUED FOR REPORT	RCG	LEL
00	MAR 11/14	ISSUED FOR REVIEW	BM	LEL
NO.	DATE	REVISIONS	BY	APPR.



PRELIMINARY ONLY
DATE PLOTTED: APR 17/14
NOT TO BE USED FOR CONSTRUCTION

PROJECT TITLE		
ESGENOÛPETITJ WWTF FEASIBILITY STUDY		
BURNT CHURCH	N.B.	
DRAWING TITLE		
EXISTING WASTEWATER SYSTEM DETAILS		
Scale	Drawn By	Design By
	BM	LEL
	Checked By	Cadd Check
	LEL	GMG
Sheet		2 of 10
File Name		
12145-1P-C102.DWG		
Drawing No.		
12145-1P-C102		

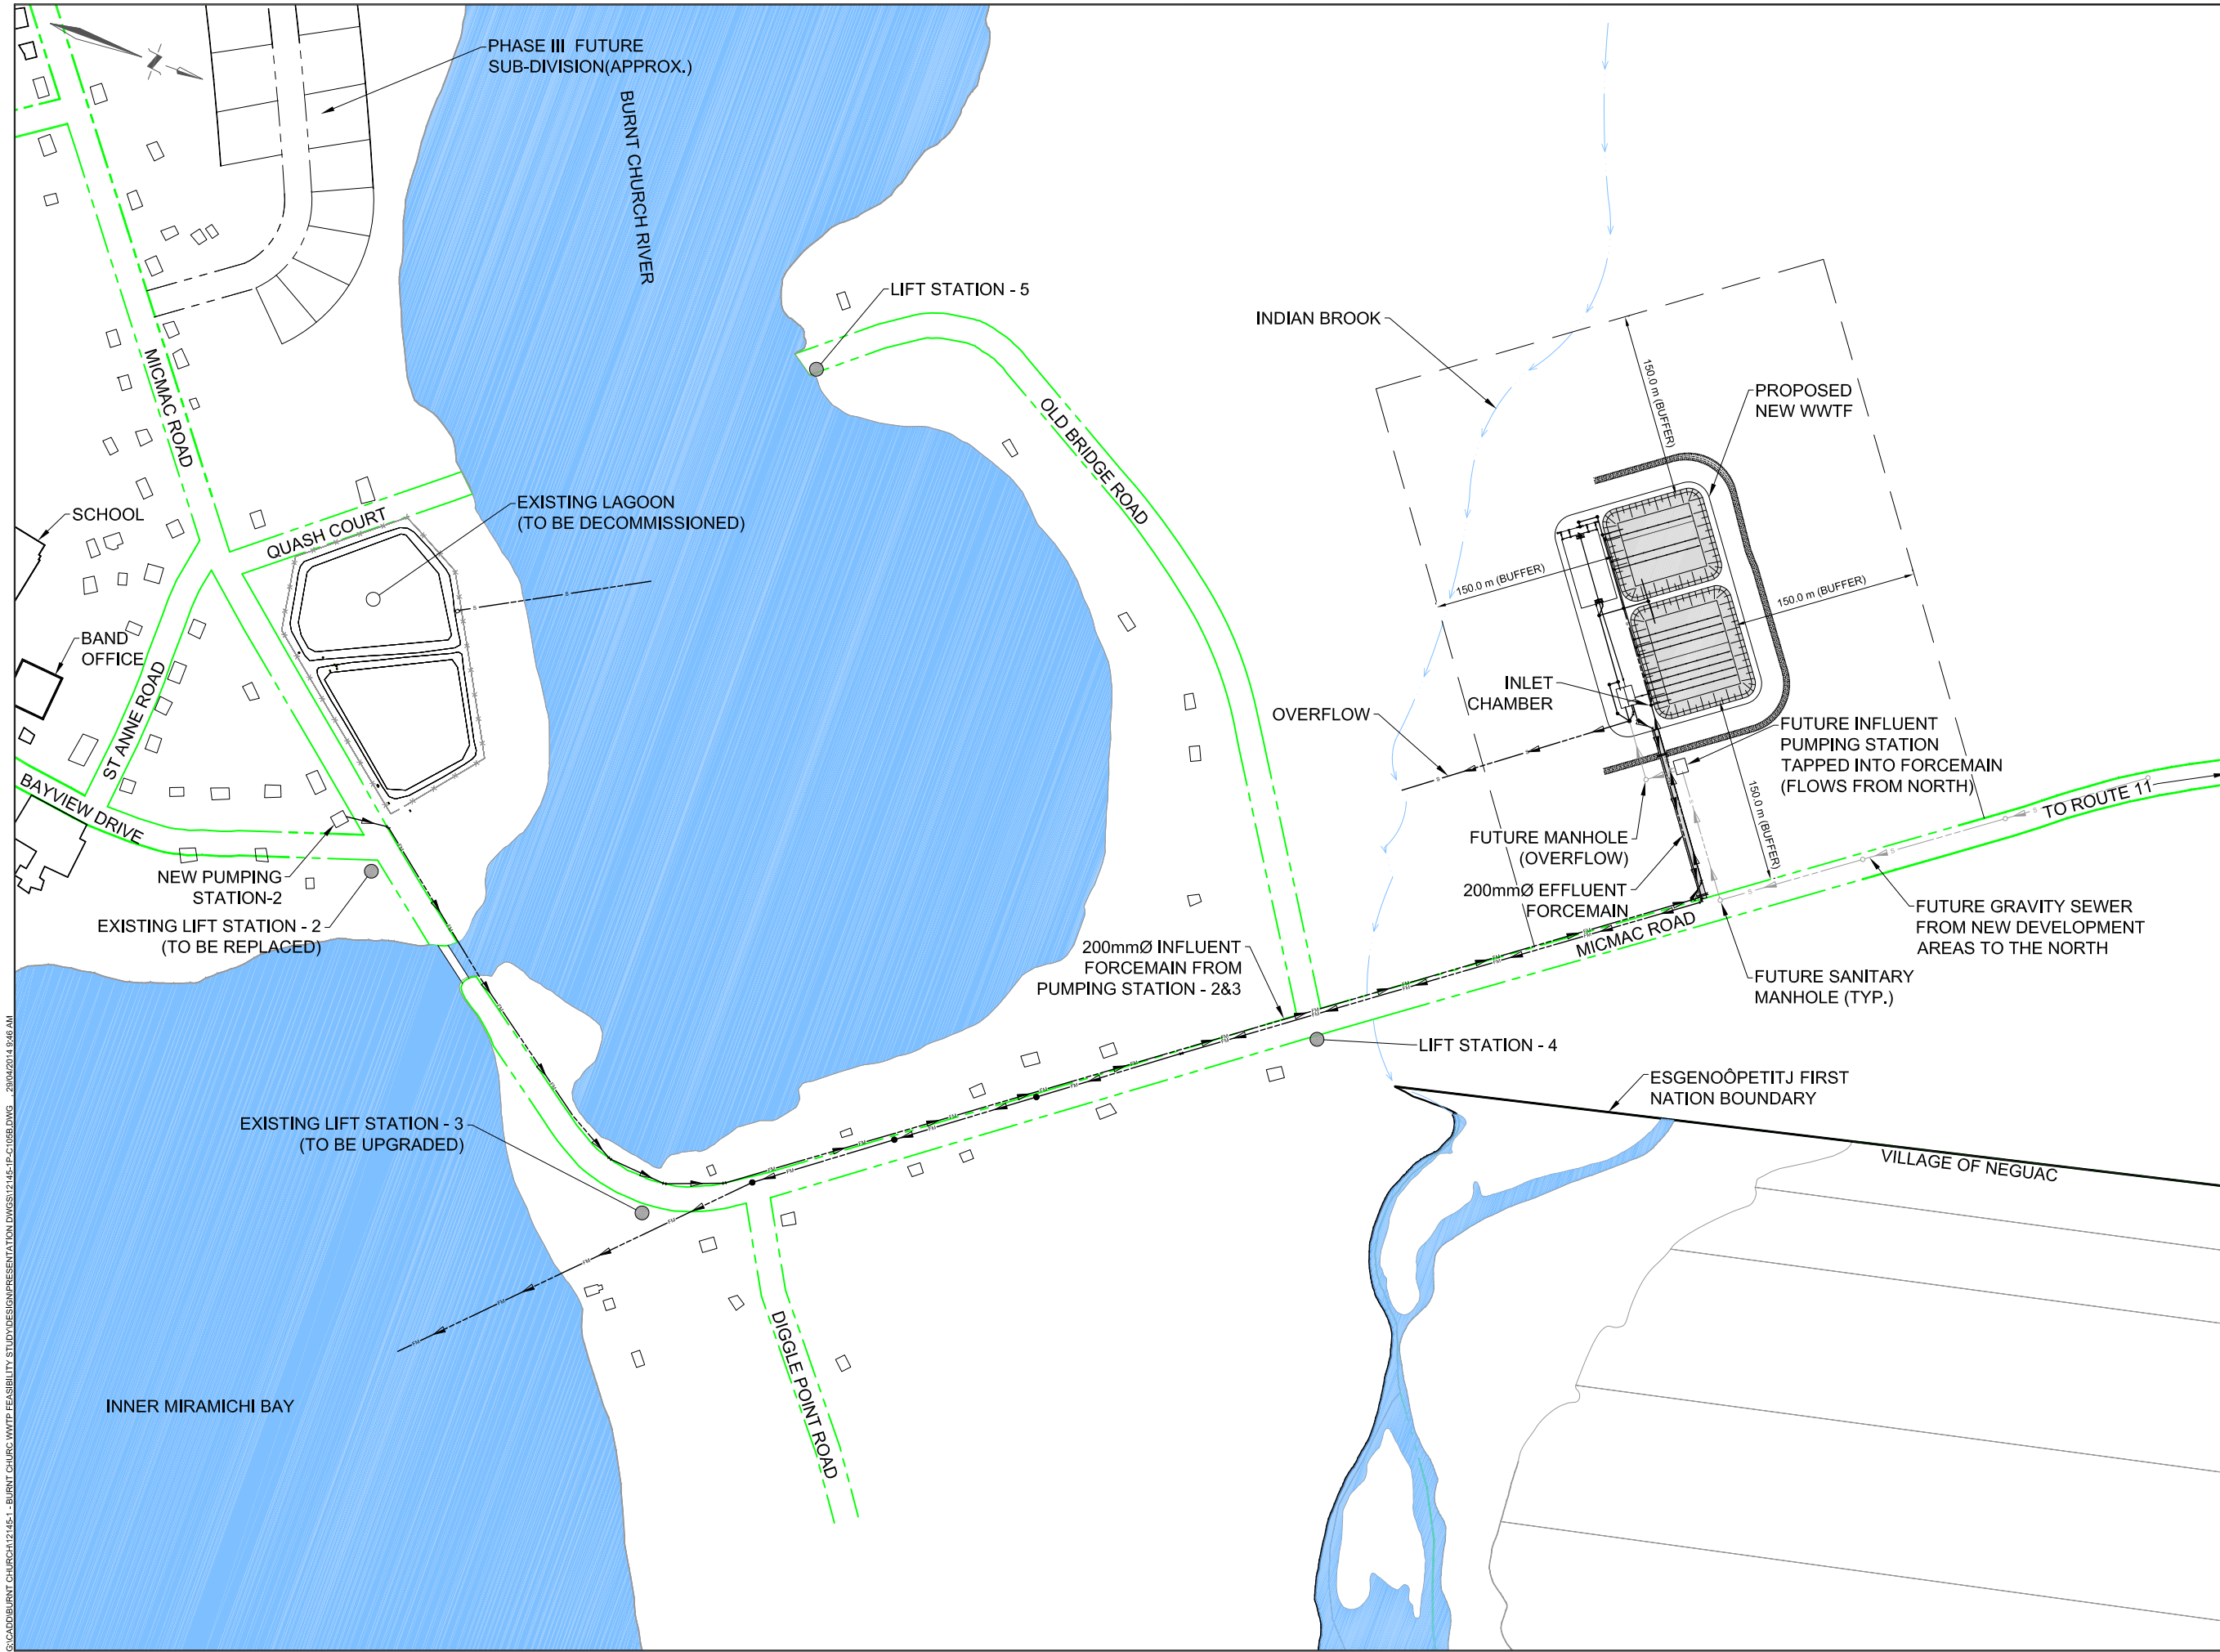

C:\CAD\BURNT CHURCH\12145-1-BURNT CHURCH WWTf FEASIBILITY STUDY\DESIGN\PRESENTATION DRAWING\12145-1P-C105B.DWG - 2008/02/14 09:45 AM

NOTES

LEGEND

- NEW FORCEMAIN
- NEW GRAVITY SEWER
- FUTURE GRAVITY SEWER
- RIGHT OF WAY
- FLOW ARROW (NEW)
- FLOW ARROW (FUTURE)
- WATERCOURSE

NOTE: REFER TO DRAWINGS C106B AND C106C FOR DETAILS ON OPTIONS 2 AND 3, RESPECTIVELY.

02	APR 17/14	ISSUED FOR REVIEW	BM	LEL
01	APR 07/14	ISSUED FOR REPORT	RCG	LEL
00	MAR 11/14	ISSUED FOR REVIEW	BM	LEL
NO.	DATE	REVISIONS	BY	APPR.



PRELIMINARY ONLY
DATE PLOTTED: APR 17/14
NOT TO BE USED FOR CONSTRUCTION


PROJECT TITLE
ESGENOÛPETITJ WWTf FEASIBILITY STUDY

BURNT CHURCH N.B.
 DRAWING TITLE
COLLECTION SYSTEM MODIFICATIONS AND NEW OUTFALL PLAN OPTIONS 2 & 3

Scale 	Drawn By	Design By
	BM	LEL
	Checked By	Cadd Check
	LEL	GMG
Sheet		6 of 10

File Name
 12145-1P-C105B.DWG

Drawing No.
 12145-1P-C105B

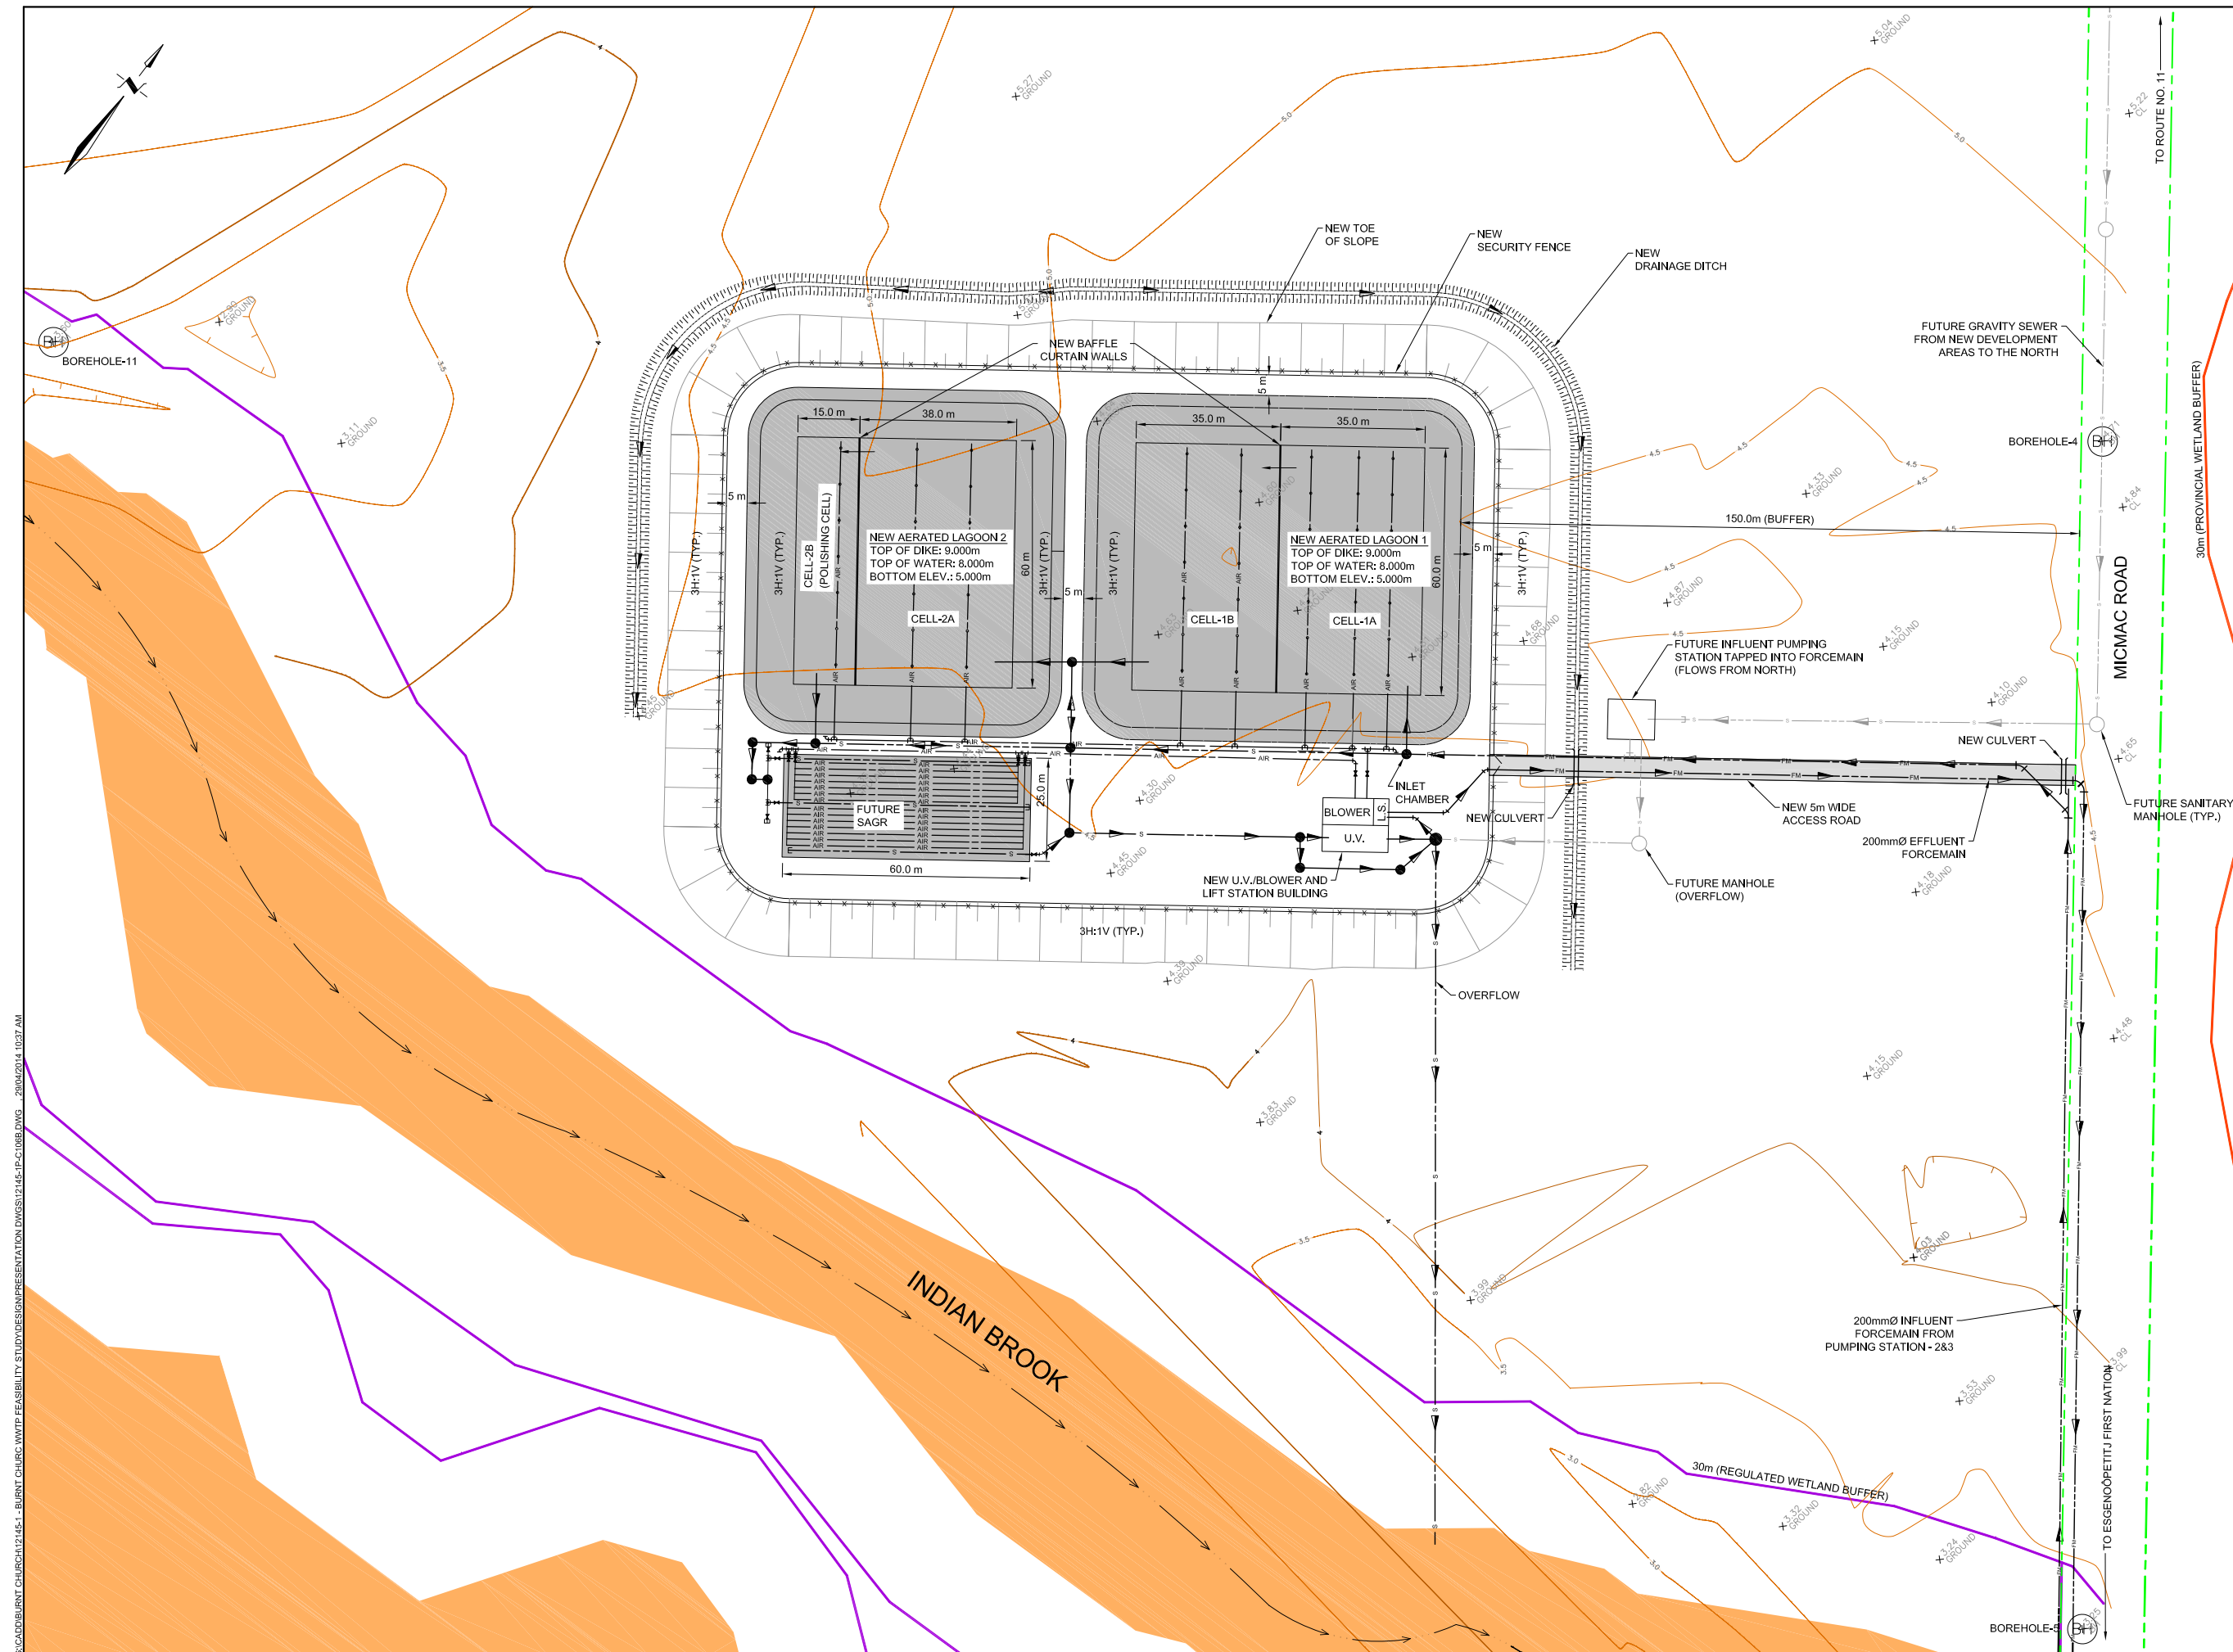

C:\CAD\BURNT CHURCH\12145-1-BURNT CHURCH WWTp FEASIBILITY STUDY\DESIGN\PRESENTATION DWG\12145-1P-C106B.DWG - 2008/02/14 10:57 AM

NOTES

LEGEND

- REGULATED WET LAND
- 30m REGULATED WETLAND BUFFER
- PROVINCIALLY SIGNIFICANT WETLAND
- 30m PROVINCIAL WETLAND BUFFER
- BOREHOLE
- NEW FORCEMAIN
- NEW GRAVITY SEWER
- FUTURE GRAVITY SEWER
- WATERCOURSE
- RIGHT OF WAY
- FLOW ARROW (NEW)
- FLOW ARROW (FUTURE)
- EXISTING SURVEY SHOT

NO.	DATE	REVISIONS	BY	APPR.
01	APR 17/14	ISSUED FOR REVIEW	BM	LEL
00	APR 15/14	ISSUED FOR REVIEW	BM	PP



PRELIMINARY ONLY

DATE PLOTTED: APR 28 2014
NOT TO BE USED FOR CONSTRUCTION

PROJECT TITLE

**ESGENOÔPETITJ
WWTp FEASIBILITY STUDY**

BURNT CHURCH N.B.

DRAWING TITLE

**NEW AERATED LAGOON
WITH FUTURE SAGR
OPTION 2**


Scale	Drawn By	Design By
7.5m 0 15m (1:750 FULL SCALE)	BM	LEL
	Checked By	Cadd Check
	PP	---
	Sheet	8 of 10

File Name

12145-1P-C106B.DWG

Drawing No.

12145-1P-C106B

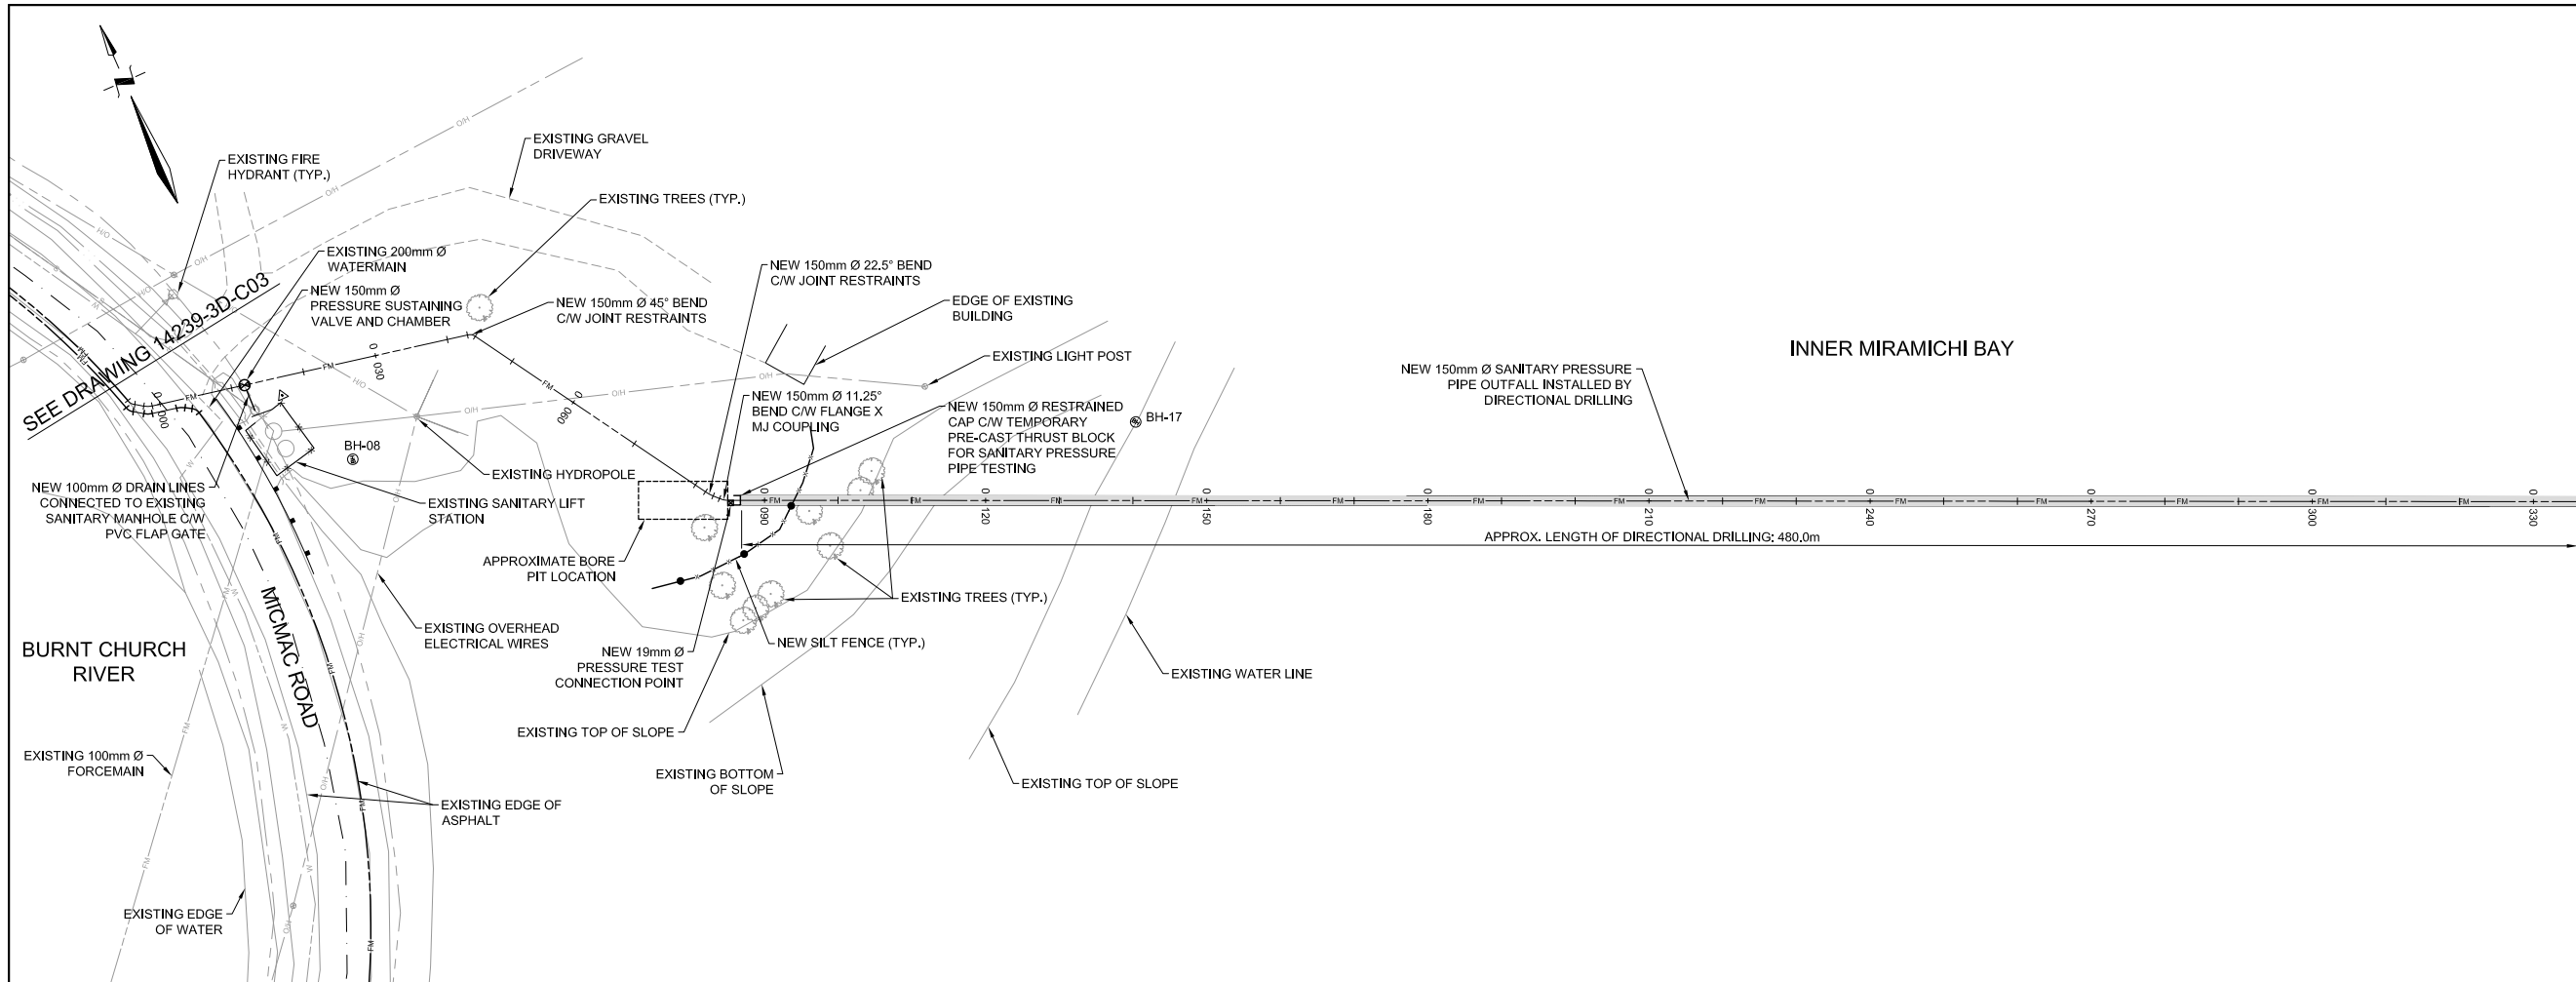


NOTES

02	MAR 06/15	ISSUED FOR 99% SUBMISSION	GMG	JAM
01	JAN 30/15	ISSUED FOR 66% SUBMISSION	GMG	JAM
00	DEC 19/14	ISSUED FOR 33% SUBMISSION	GMG	PP
NO.	DATE	REVISIONS	BY	APPR.



PRELIMINARY ONLY
DATE PLOTTED: APR 09, 2015
NOT TO BE USED FOR CONSTRUCTION

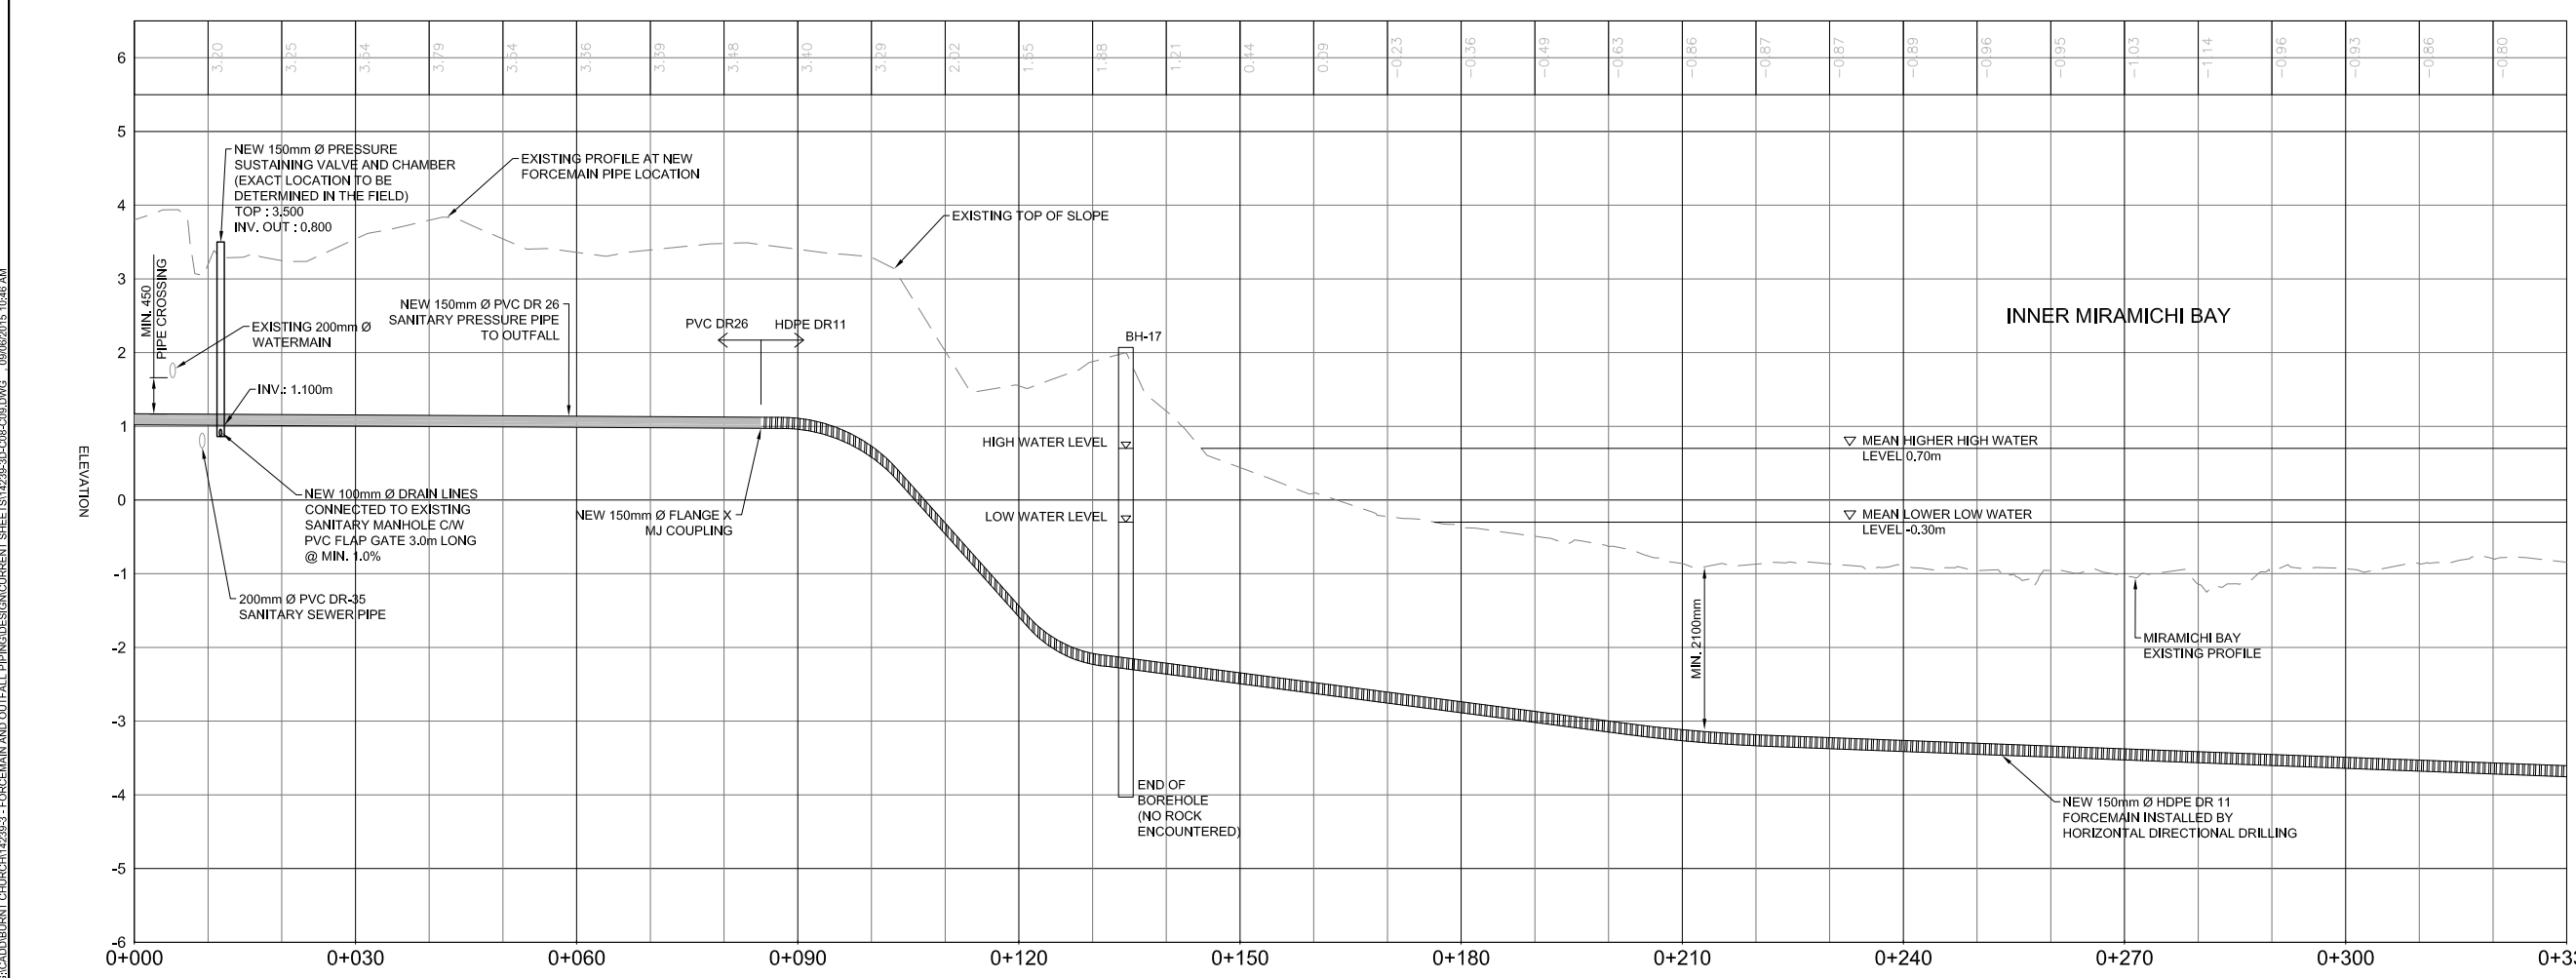

PROJECT TITLE

ESGENOOPETITJ FIRST NATION WASTEWATER SYSTEM UPGRADE CONTRACT NO. 1 - FORCEMAIN PIPING AND OUTFALL

BURNT CHURCH N.B.

DRAWING TITLE

OUTFALL PLAN AND PROFILE STA. 0+000 TO STA. 0+330


Scale	Drawn By	Design By
5m 1:500 Horizontal (Full Scale)	GMG	GMG
.5m 1:50 Vertical (Full Scale)	Checked By	Cadd Check
	JAM	---
	Sheet	8 of 11

File Name: 14239-3D-C08-C09.DWG

Drawing No.: 14239-3D-C08

C:\CAD\BURNT CHURCH\14239-3D-FORCEMAIN AND OUTFALL PIPING\DESIGN\CURRENT SHEET\14239-3D-C08-C09.DWG 09/09/2015 10:36 AM

SEE DRAWING 14239-3D-C08

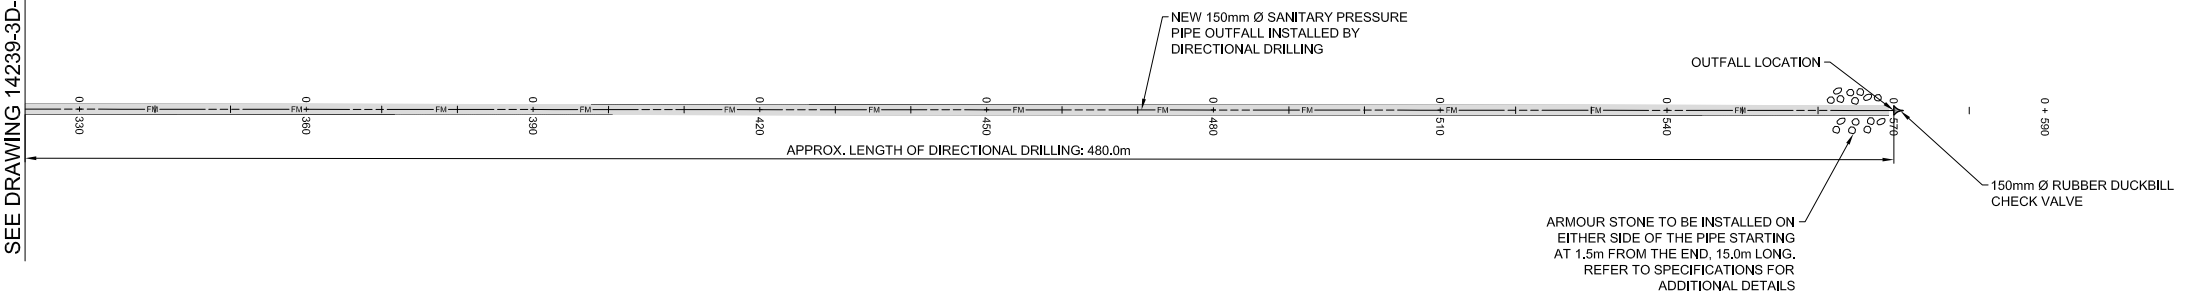

INNER MIRAMICHI BAY

02	MAR 06/15	ISSUED FOR 99% SUBMISSION	GMG	JAM
01	JAN 30/15	ISSUED FOR 66% SUBMISSION	GMG	JAM
00	DEC 19/14	ISSUED FOR 33% SUBMISSION	GMG	PP
NO.	DATE	REVISIONS	BY	APPR.



PRELIMINARY ONLY
DATE PLOTTED: April 2015
NOT TO BE USED FOR CONSTRUCTION

PROJECT TITLE
ESGENOO PETITJ FIRST NATION WASTEWATER SYSTEM UPGRADE CONTRACT NO. 1 - FORCEMAIN PIPING AND OUTFALL


BURNT CHURCH N.B.

DRAWING TITLE
OUTFALL PLAN AND PROFILE STA. 0+330 TO STA. 0+590

Scale	Drawn By	Design By
	GMG	GMG
	Checked By	Cadd Check
	JAM	---
	Sheet	9 of 11

File Name
 14239-3D-C08-C09.DWG

Drawing No.
14239-3D-C09

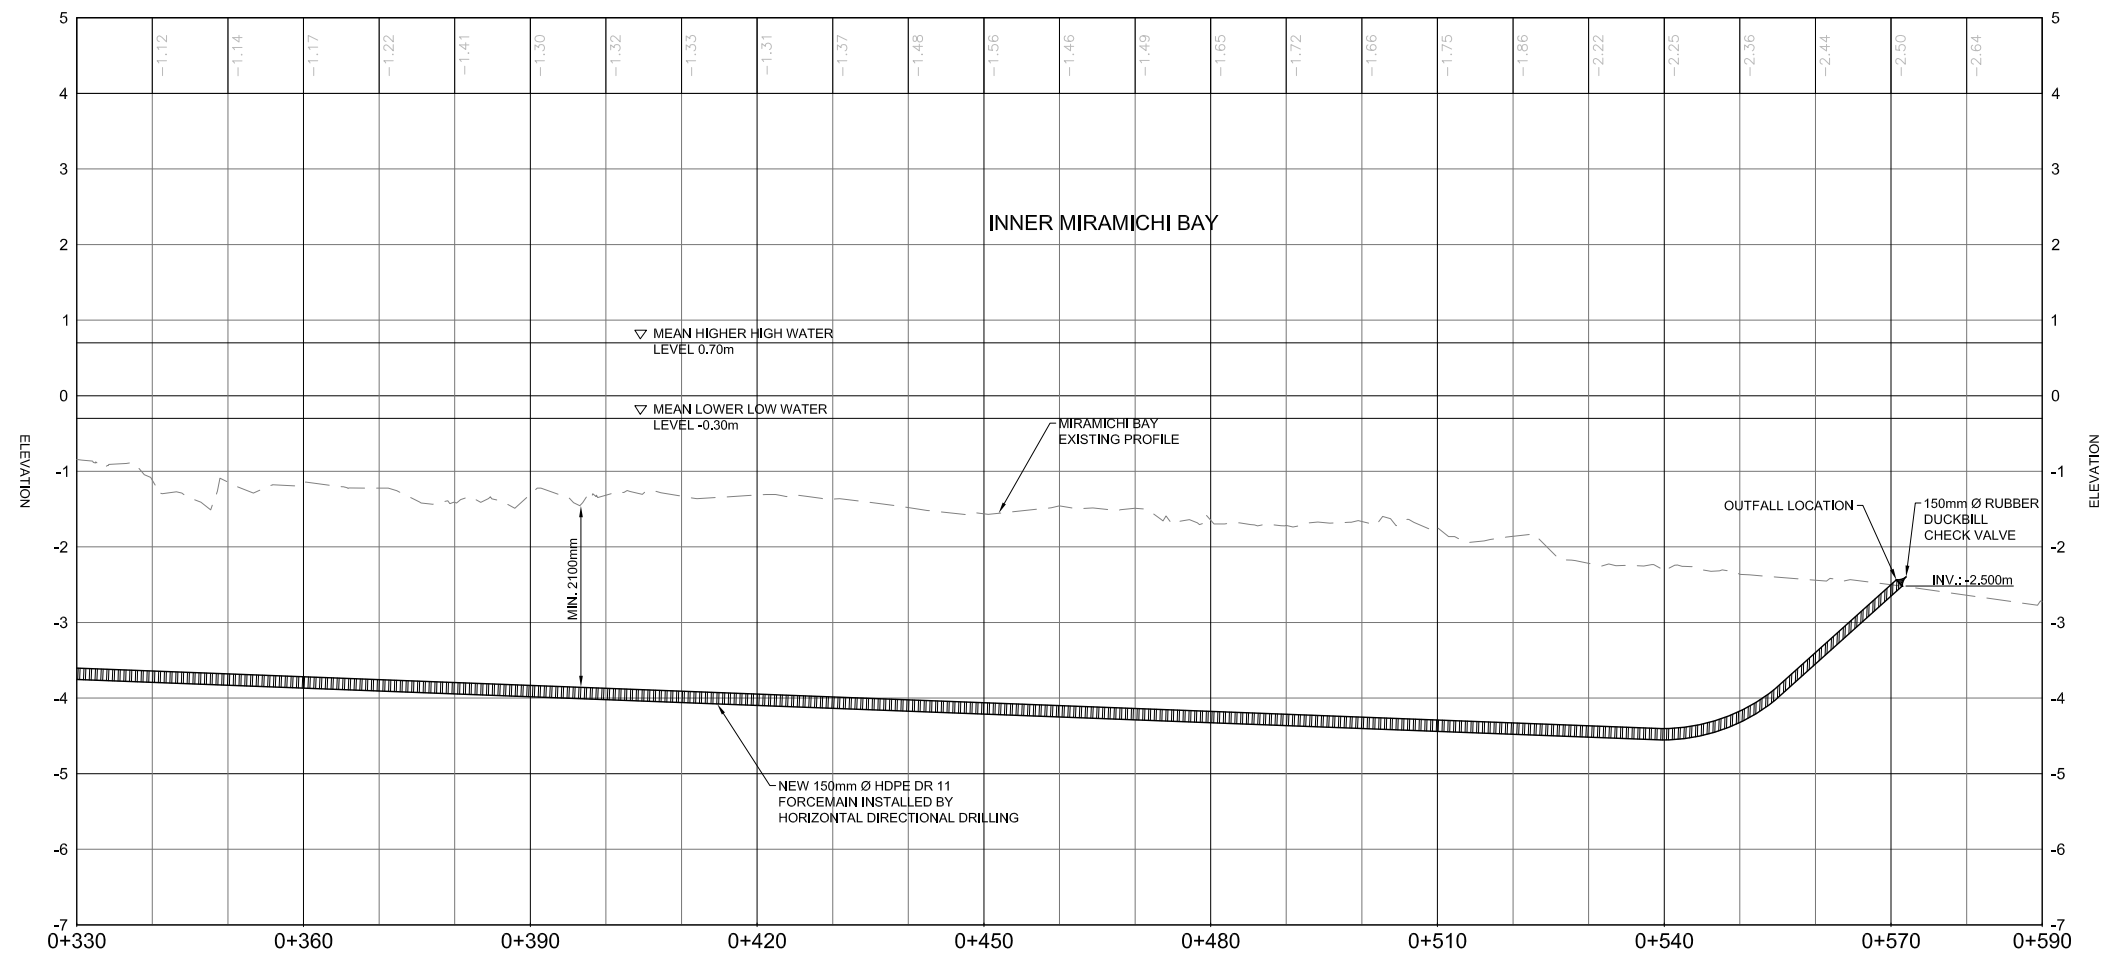

S:\CAD\BURNT CHURCH\14239-3- FORCEMAIN AND OUTFALL PIPING\DESIGN\CURRENT SHEET\14239-3D-C08-C09.DWG 09/02/2015 10:57 AM